



MECON LIMITED

CORRIGENDUM#2

**TENDER DOCUMENT FOR
CONSTRUCTION OF CNG STATION (GREEN FIELD AND AT DAUGHTER BOOSTER
STATIONS/ RETAIL OUTLETS/ DEALER'S STATIONS) AT CACHAR, HAILAKANDI &
KARIMGANJ GA AND KAMRUP & KAMRUP METROPOLITAN GA (2 YEARS ANNUAL RATE
CONTRACT (ARC)) FOR M/S PBGPL**

Tender No.: 05/51/23VM/PBGPL/001-iv

Dated: 17.12.2021

The terms and conditions of the Bidding Document stands modified to the extent indicated below and all other terms and conditions of the Bidding Document remains unaltered:


Sn. No.	Volume of Bidding Document	Section	Page No.	Clause No.	Clause Description	Additions / Deletions / Modifications
1.	Vol II of II	Electrical	951	NA	Tender SLD	Addition of Single Line Diagram which is the Part of SOR Item No.1.0- Attachment 1 enclosed herewith.
2.	Vol II of II	Electrical	956	NA	Block Diagram	Addition of Block diagram of Uninterrupted Power Supply SOR Item No. 12.0.- Attachment 2 enclosed herewith.

Note: This Corrigendum shall form an integral part of the bidding document and shall be signed/stamped and submitted along with the bid.

(STAMP & SIGNATURE OF BIDDER)


Attachment 1



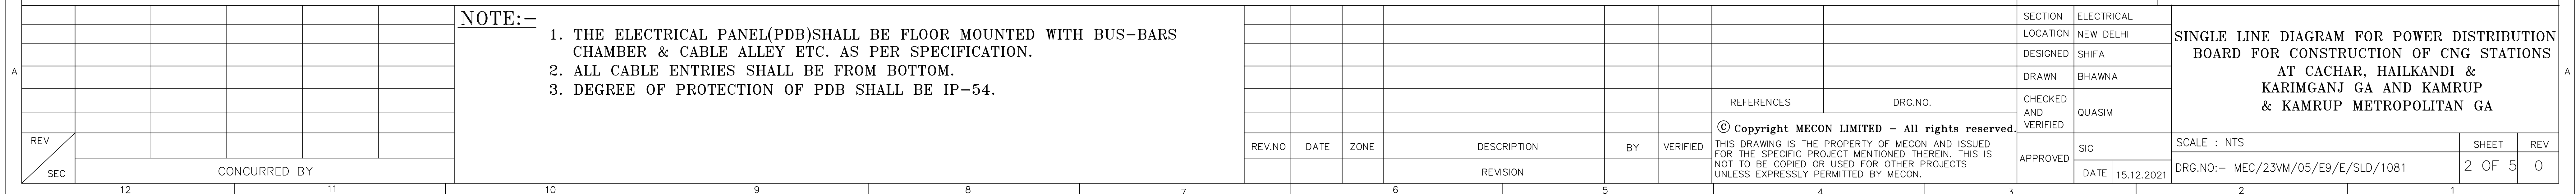

LEGEND

	AMMETER		CURRENT TRANSFORMER
	AMMETER SELECTOR SWITCH		TRI VECTOR METER
	VOLTMETER		FREQUENCY METER
	VOLTMETER SELECTOR SWITCH		DRAW OUT
	KILOWATT HOUR METER		EARTHING
	TRANSFORMER (POTENTIAL CONTROL)		CABLE GLAND
	INDICATION LAMP		HRC FUSE
	MCCB+ELR		SELECTOR SWITCH
	CONTACTOR		AIR CKT BREAKER
	O/L RELAY		SWITCH FUSE UNIT
	MCB		VACCUUM CIRCUIT BREAKER
	ON OFF TRIP INDICATION		MCCB
	MOTOR PROTECTION CIRCUIT BREAKER		

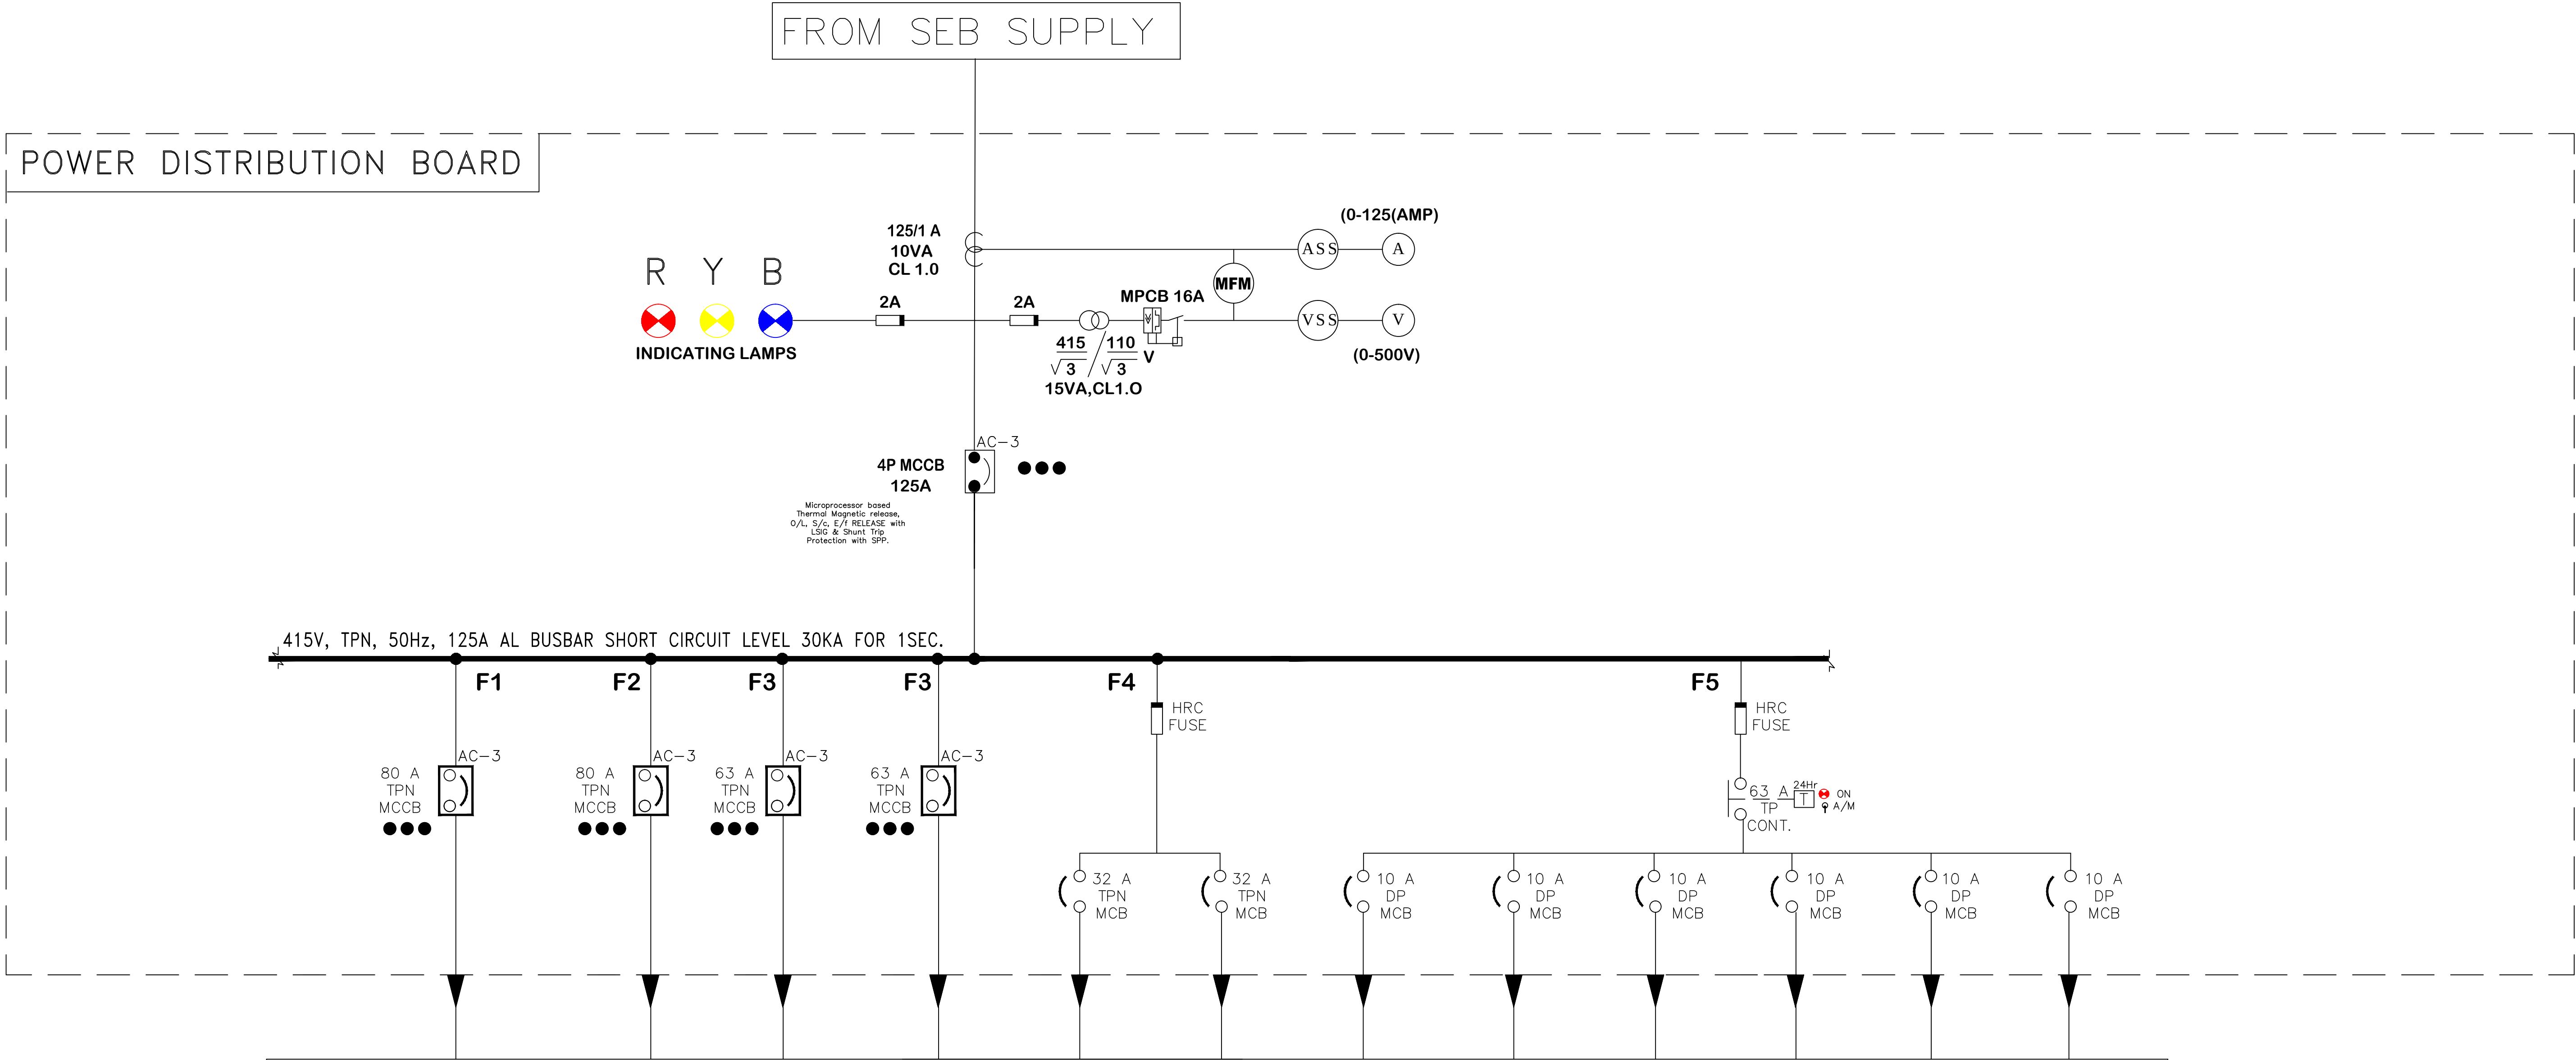

POWER DISTRIBUTION BOARD FEEDER DETAILS

FEEDER TYPE	TPN MCCB	TPN MCCB	TPN MCCB	TPN MCCB	TPN MCB	TPN MCB	DP MCB	DP MCB	DP MCB	DP MCB	DP MCB	DP MCB
LOAD DETAILS												
RATING												
CABLE SIZE												

FOR TENDER PURPOSE ONLY

	PURBA BHARATI GAS PRIVATE LIMITED
	मेकॉन लिमिटेड
	MECON LIMITED
SECTION ELECTRICAL	SINGLE LINE DIAGRAM FOR POWER DISTRIBUTION BOARD FOR CONSTRUCTION OF CNG STATIONS AT CACHAR, HAILKANDI & KARIMGANJ GA AND KAMRUP & KAMRUP METROPOLITAN GA
LOCATION NEW DELHI	
DESIGNED SHIFA	
DRAWN BHAWNA	
CHECKED AND VERIFIED QUASIM	SCALE : NTS
SIG	
APPROVED	DATE 15.12.2021
DRG.NO:- MEC/23VM/05/E9/E/SLD/1081	
SHEET 3 OF 5	
REV 0	

NOTE:-


1. THE ELECTRICAL PANEL(PDB)SHALL BE FLOOR MOUNTED WITH BUS-BARS CHAMBER & CABLE ALLEY ETC. AS PER SPECIFICATION.
2. ALL CABLE ENTRIES SHALL BE FROM BOTTOM.
3. DEGREE OF PROTECTION OF PDB SHALL BE IP-54.


REFERENCES

DRG.NO.


© Copyright MECON LIMITED - All rights reserved. THIS DRAWING IS THE PROPERTY OF MECON AND ISSUED FOR THE SPECIFIC PROJECT MENTIONED THEREIN. THIS IS NOT TO BE COPIED OR USED FOR OTHER PROJECTS UNLESS EXPRESSLY PERMITTED BY MECON.

REV	DATE	ZONE	DESCRIPTION	BY	VERIFIED
SEC					
CONCURRED BY					

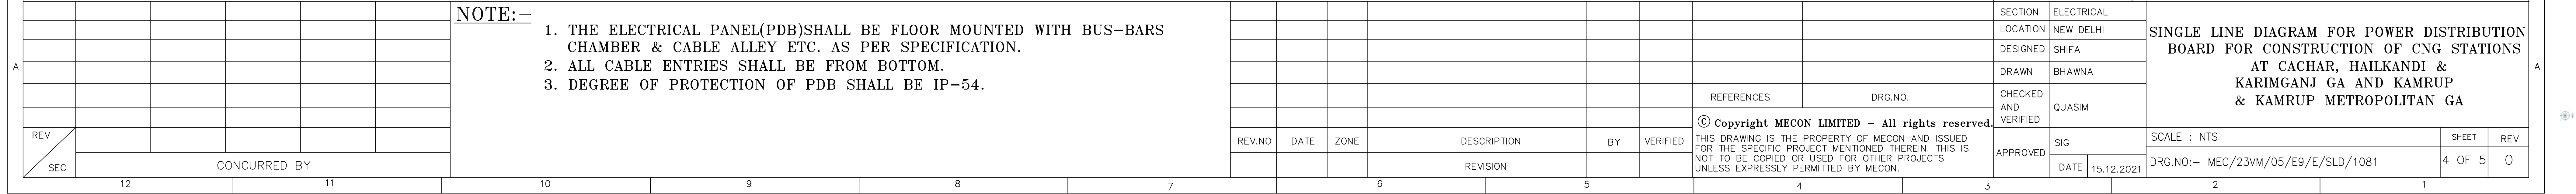

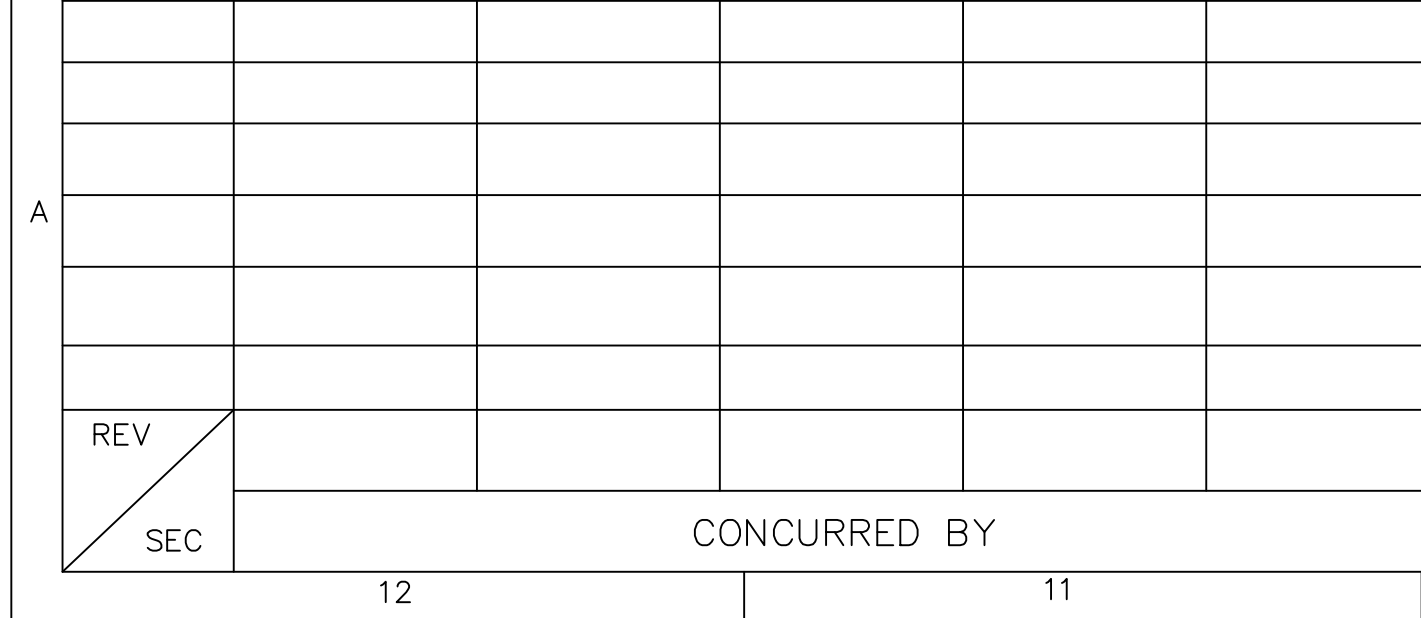

Attachment 2

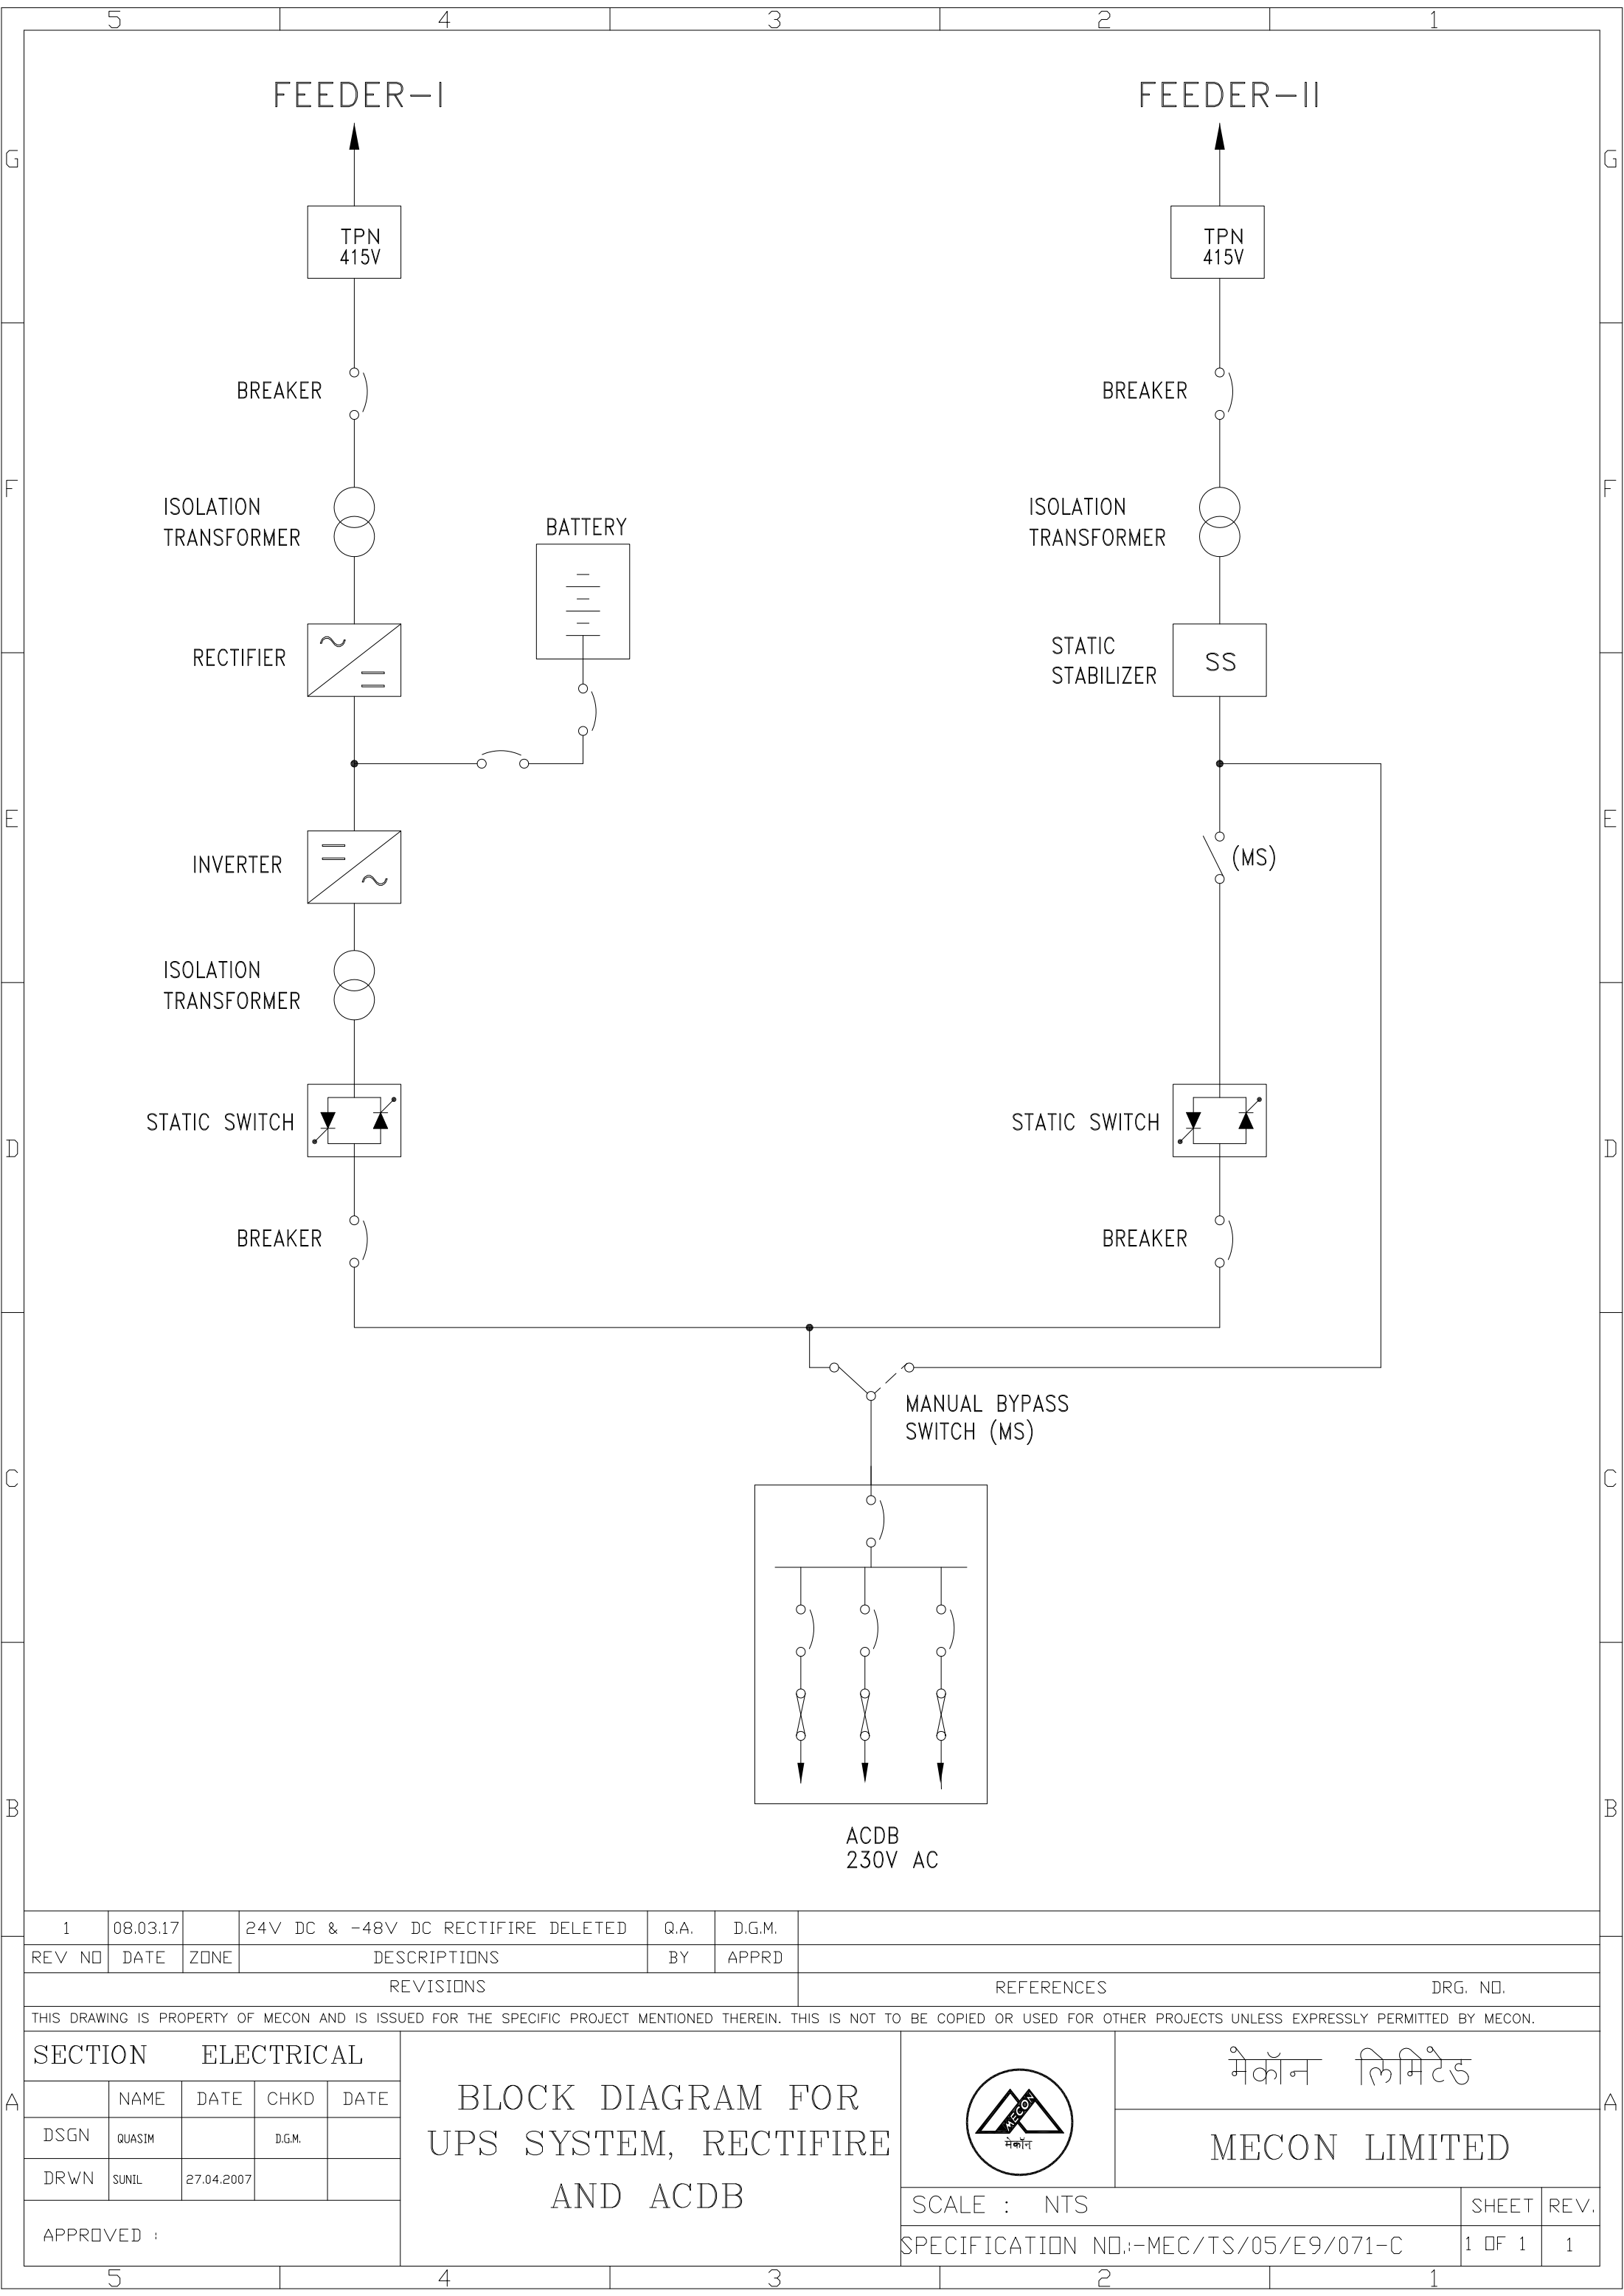

1	08.03.17		24V DC & -48V DC RECTIFIRE DELETED		Q.A.	D.G.M.								
REV NO	DATE	ZONE	DESCRIPTIONS			BY	APPRD							
REVISIONS							REFERENCES			DRG. NO.				
THIS DRAWING IS PROPERTY OF MECON AND IS ISSUED FOR THE SPECIFIC PROJECT MENTIONED THEREIN. THIS IS NOT TO BE COPIED OR USED FOR OTHER PROJECTS UNLESS EXPRESSLY PERMITTED BY MECON.														
SECTION ELECTRICAL					BLOCK DIAGRAM FOR UPS SYSTEM, RECTIFIRE AND ACDB							मैकॉन लिमिटेड		
	NAME	DATE	CHKD	DATE								MECON LIMITED		
DSGN	QUASIM		D.G.M.						SCALE : NTS				SHEET	REV.
DRWN	SUNIL	27.04.2007												
APPROVED :									SPECIFICATION NO.:-MEC/TS/05/E9/071-C				1 OF 1	1